


### LEGEND

- 70 - EXISTING CONTOUR 2M INTERVALS
- 70 - PROPOSED CONTOUR 2M INTERVALS
- TPZ - TREE PROTECTION ZONE TEMP FENCE
- NVPZ - NATIVE VEG PROTECTION ZONE TEMP FENCE
- EXISTING WETLANDS / NATIVE VEGETATION

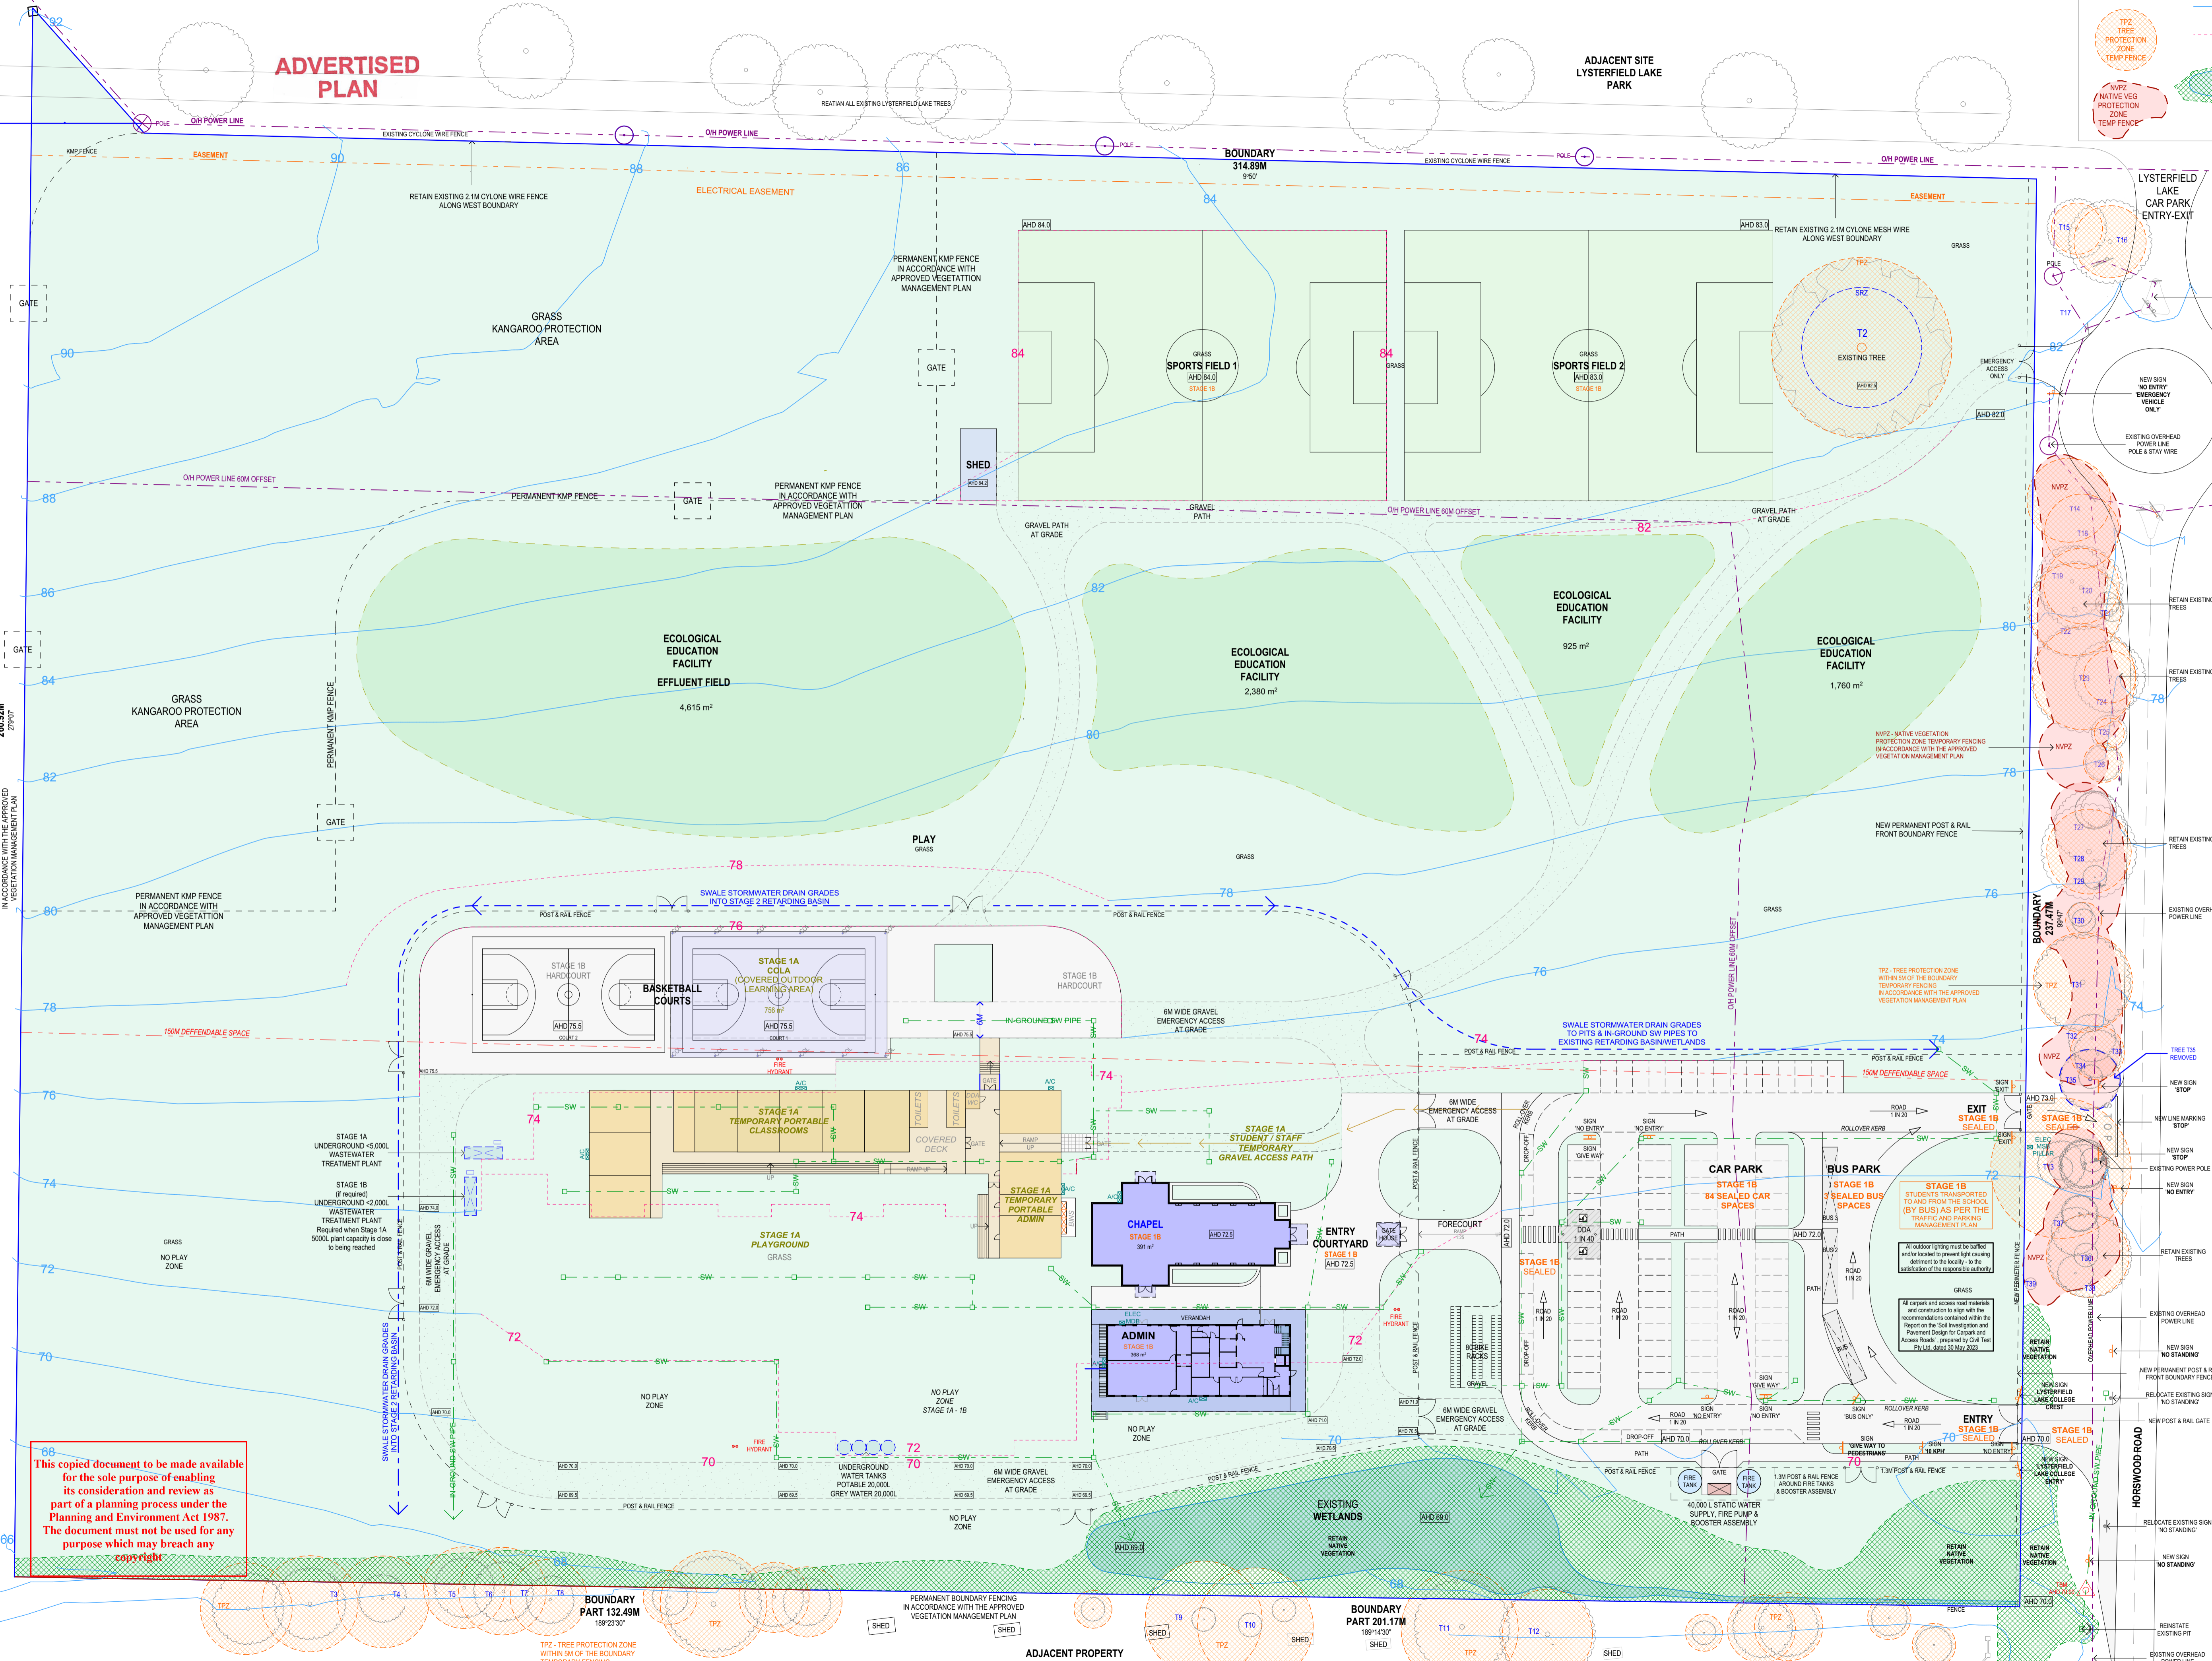

STAGE 1A	STAGE 1B	STAGE 2
<b>PERMANENT FACILITIES</b> WASTEWATER TREATMENT PLANT (STAGE 1A) WASTEWATER TREATMENT PLANT (STAGE 1B) WASTEWATER TREATMENT PLANT (STAGE 2) SWALE STORMWATER DRAIN GRADES INTO STAGE 2 RETARDING BASIN TOTAL STAGE 1A FACILITIES: 2,845 m <sup>2</sup>	<b>PERMANENT FACILITIES</b> BASKETBALL COURTS CHAPEL ADMIN STAGE 1A STUDENT / STAFF TEMPORARY GRAVEL ACCESS PATH STAGE 1A PLAYGROUND STAGE 1A TEMPORARY PORTABLE CLASSROOMS STAGE 1A UNDERGROUND WASTEWATER TREATMENT PLANT STAGE 1B UNDERGROUND WASTEWATER TREATMENT PLANT STAGE 1B PLAYGROUND STAGE 1B TEMPORARY PORTABLE CLASSROOMS STAGE 1B UNDERGROUND WASTEWATER TREATMENT PLANT TOTAL STAGE 1B FACILITIES: 2,241 m <sup>2</sup>	<b>PERMANENT FACILITIES</b> SPORTS FIELD 1 SPORTS FIELD 2 ECOLOGICAL EDUCATION FACILITY ECOLOGICAL EDUCATION FACILITY ECOLOGICAL EDUCATION FACILITY PLAY GRASS GRASS KANGAROO PROTECTION AREA GRASS KANGAROO PROTECTION AREA TOTAL STAGE 2 FACILITIES: 2,845 m <sup>2</sup>

THIS DESIGN AND DRAWING IS PROTECTED BY COPYRIGHT & REMAINS THE PROPERTY OF CULLEN ARCHITECTS. THIS DRAWING IS TO BE USED SOLELY FOR THE PURPOSES INDICATED IN THE DRAWING TITLE AND IS NOT TO BE USED FOR ANY OTHER PURPOSE UNLESS APPROVED IN WRITING BY CULLEN ARCHITECTS.

FIGURED DIMENSIONS TAKE PRECEDENCE. DO NOT SCALE THE DRAWING. ALL LEVELS & DIMENSIONS ARE TO BE VERIFIED PRIOR TO COMMENCEMENT ON SITE. REPORT ANY DISCREPANCY TO CULLEN ARCHITECTS FOR APPROVAL PRIOR TO PROCEEDING WITH WORKS.

**CULLEN ARCHITECTS**  
 603/279 Wellington Parade South  
 East Melbourne Vic 3002  
 admin@cullenarchitects.com.au  
 +61 400 000 530  
 AON 117 330 113



Project:  
**LYSTERFIELD LAKE COLLEGE  
 NEW SCHOOL**

At:  
**19-23 HORSWOOD ROAD  
 NARRE WARREN NORTH VIC**

Issue:  
**PLANNING PERMIT AMENDMENT**

Job No:  
**CA1901\_LLC**

Drawing Name:  
**SITE PLAN - STAGE 1B  
 GROUND FLOOR LEVEL**

Sheet Size: Scale: Date:  
 A1 1:500 12/01/2026

Revision:  
**PA2302660  
 1B WASTE WATER TANK**

Drawing No.:  
**TP07-1B**

This copied document to be made available for the sole purpose of enabling its consideration and review as part of a planning process under the Planning and Environment Act 1987. The document must not be used for any purpose which may breach any copyright.