


4. PROPOSED PLANS

4.2 PROPOSED FLOOR PLANS - BASEMENT LEVEL

ADVERTISED PLAN

Complete design, installation, operation and maintenance of the rain water catchment, roof plumbing, storage, pumping, filtration and reticulation systems are to be in accordance with all regulations and industry standards such as (but not limited to): Victorian Building Authority; HB 230-2008 Rainwater Tank Design and Installation Handbook; and all manufacturer recommendations.

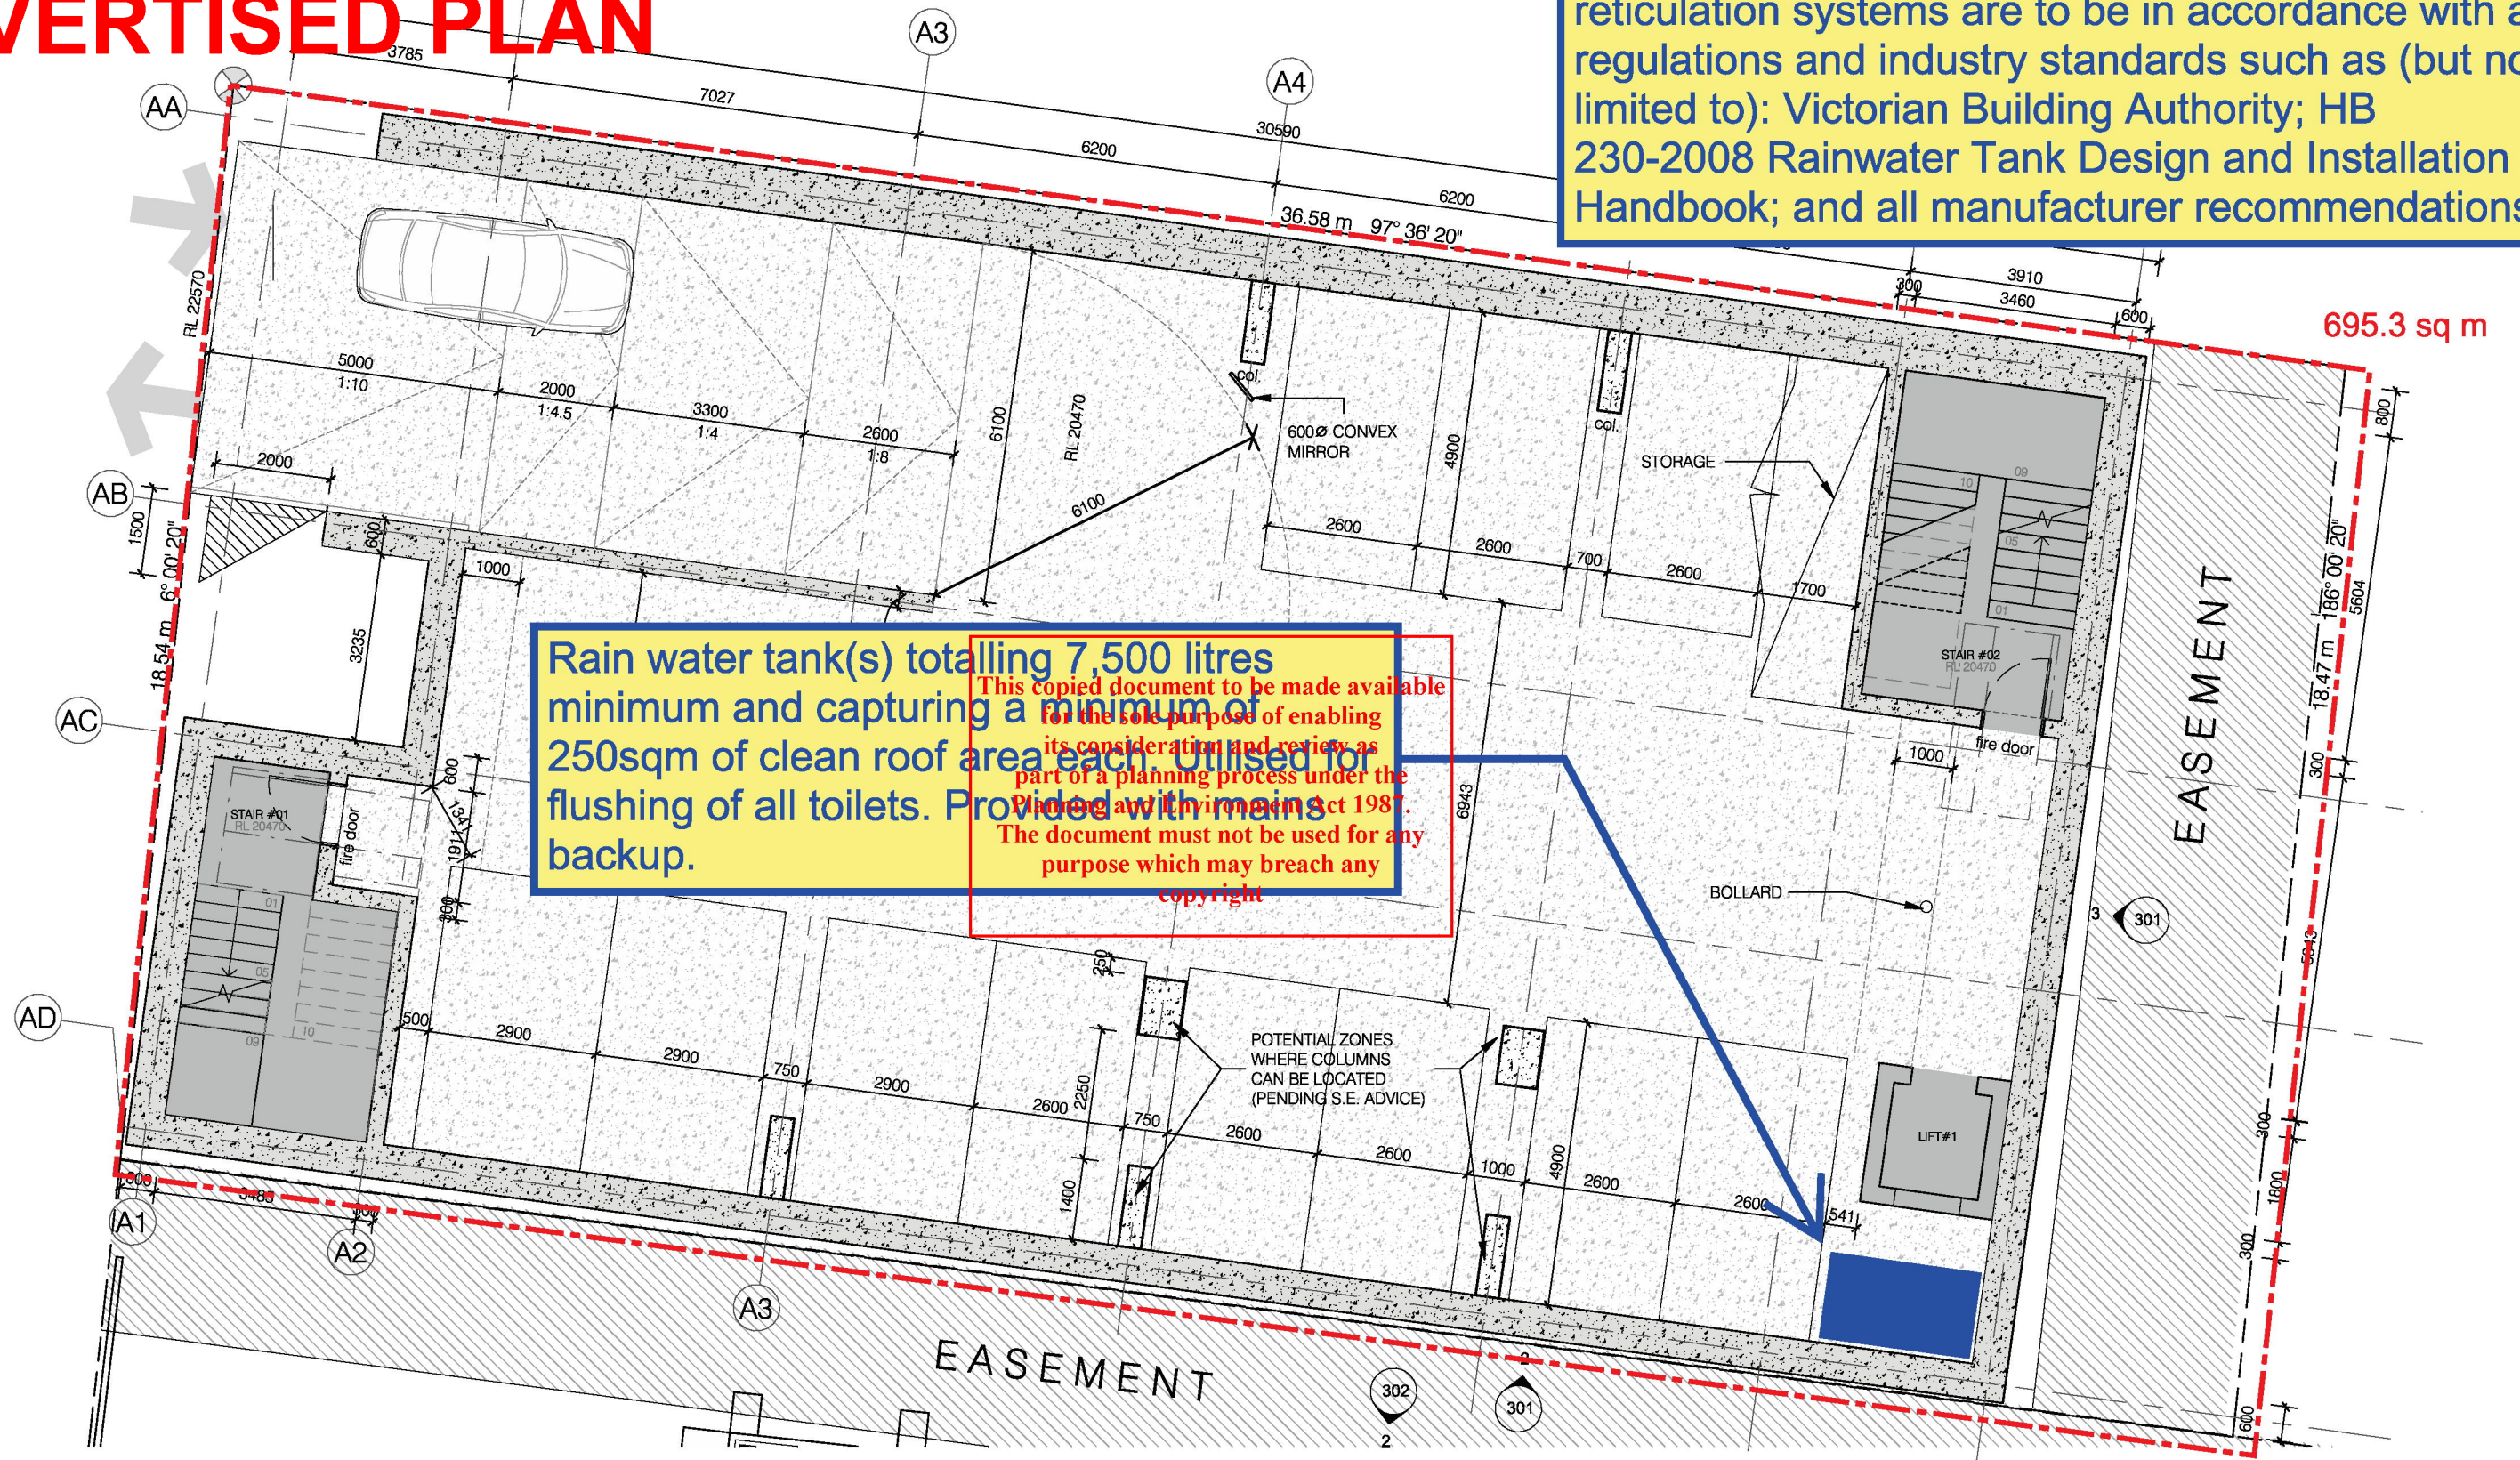


PROJECT
MELBOURNE MONTESSORI COLLEGE
STAGE 1
741 HAWTHORN ROAD BRIGHTON EAST

DRAWING
PROPOSED BASEMENT LEVEL
FOOD TECHNOLOGY & C4 BUILDING
DRAWN BY
Author
SCALE
1: 100
DATE
JANUARY 2025
DRAWING NUMBER
SD2419/204/

4. PROPOSED PLANS

4.2 PROPOSED FLOOR PLANS - GROUND FLOOR LEVEL

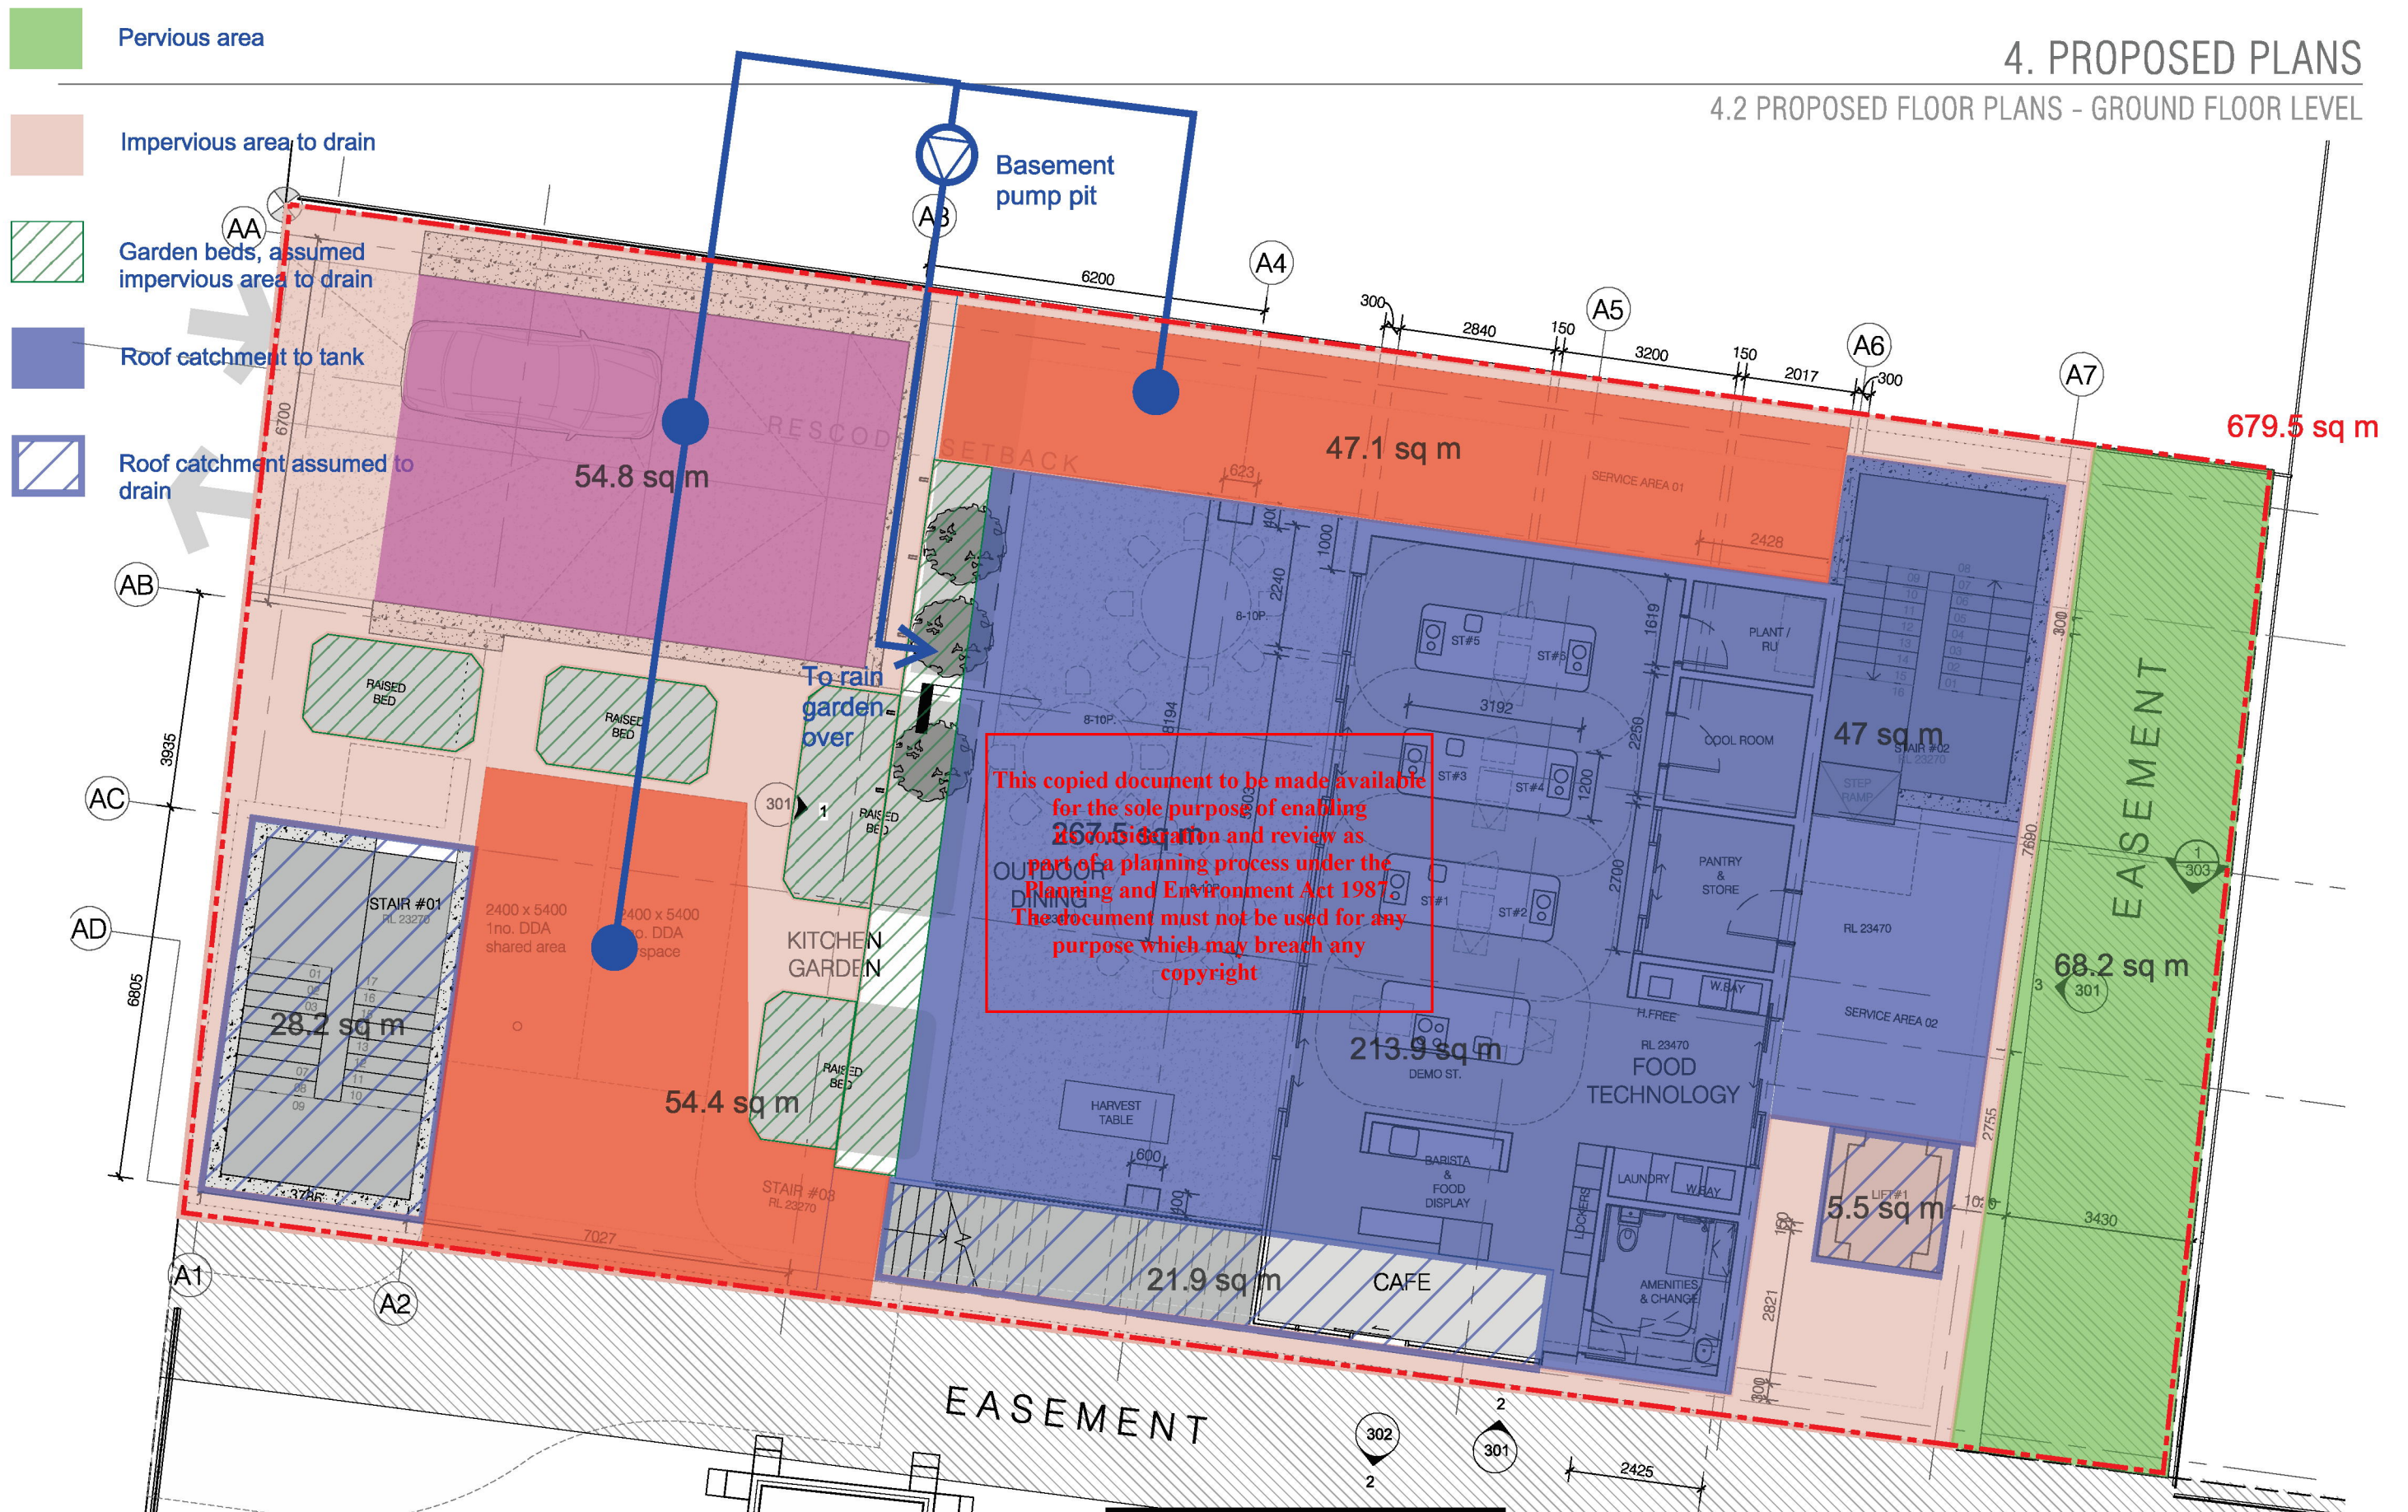

SCHEMATIC DESIGN
NOT FOR CONSTRUCTION
THIS DRAWING AND DESIGN REMAIN THE COPYRIGHT OF KNEELER DESIGN PTY LTD.




PROJECT: MELBOURNE MONTESSORI COLLEGE
STAGE 1
741 HAWTHORN ROAD BRIGHTON EAST

DRAWING: PROPOSED GROUND LEVEL FOOD TECHNOLOGY & C4 BUILDING	
DRAWN BY: Author	DATE: JANUARY 2025
SCALE: 1:100	DRAWING NUMBER: SD2419/205/

4. PROPOSED PLANS

4.2 PROPOSED FLOOR PLANS - FIRST FLOOR LEVEL

This copied document to be made available for the sole purpose of enabling its consideration and review as part of a planning process under the Planning and Environment Act 1987. The document must not be used for any purpose which may breach any copyright

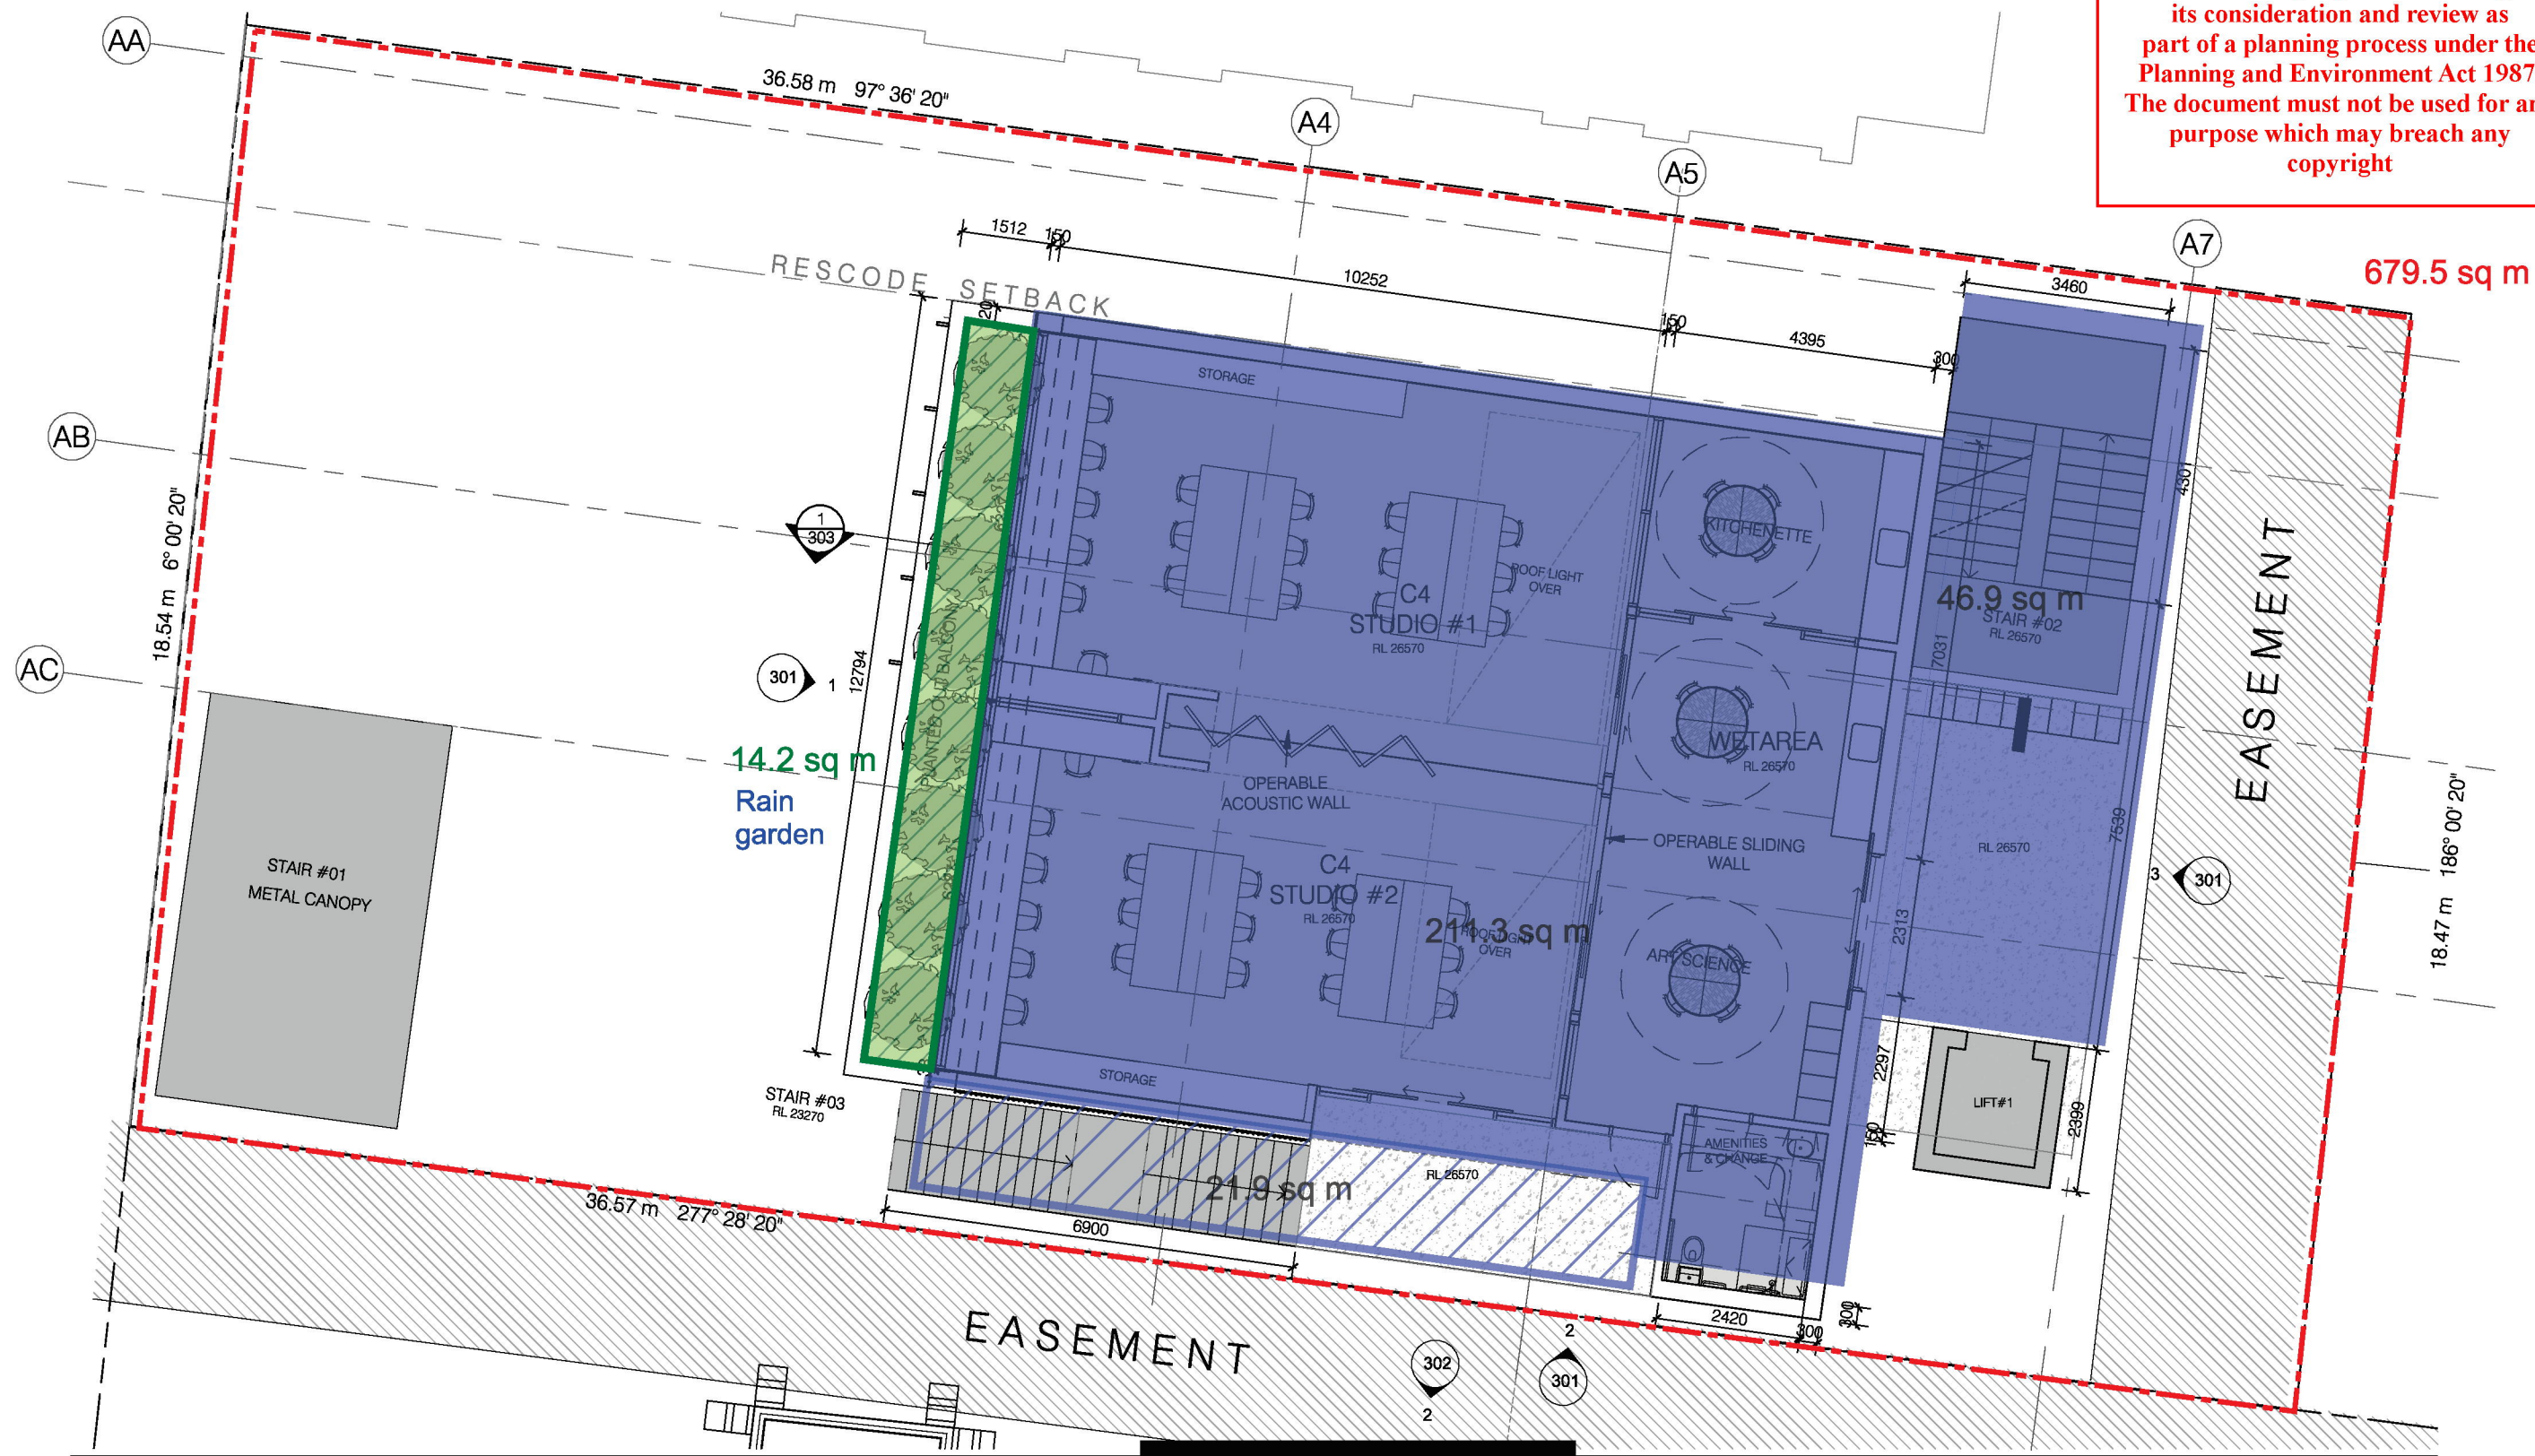

SCHEMATIC DESIGN
NOT FOR CONSTRUCTION
THIS DRAWING AND DESIGN REMAIN THE COPYRIGHT OF KNEELER DESIGN PTY LTD.



PROJECT
MELBOURNE MONTESSORI COLLEGE
STAGE 1
741 HAWTHORN ROAD BRIGHTON EAST



DRAWING
PROPOSED FIRST LEVEL
FOOD TECHNOLOGY & C4 BUILDING

DRAWN BY Author	DATE JANUARY 2025
SCALE 1: 100	DRAWING NUMBER SD2419/206/

4. PROPOSED PLANS

4.2 PROPOSED ROOF PLAN

